



# Q-Kids Daycare Center

Municipal Address: 420 WEBSTER AVENUE  
Legal Description: LOT 1 BLOCK 1 DISTRICT LOT 704 CARIBOO DISTRICT PLAN 6719

ISSUED FOR  
BP / TENDER  
JUNE 24, 2022  
urbansystems.ca



## Drawing List

### Sheet Title

- |     |                 |
|-----|-----------------|
| C00 | COVER           |
| C01 | LEGEND          |
| C02 | REMOVALS        |
| C03 | SITE PLAN       |
| C04 | GRADING PLAN    |
| C05 | GRADING DETAILS |
| C06 | SIGNING & PAINT |
| C07 | DETAILS         |
| C08 | SECTIONS        |

SITE LOCATION  
0 20 40m  
1:1000










U:\Projects\_KAM\1190\0200\01\10\Design\CAD\20\_PROD\SET\_1\02\_1190020001 SITE PLAN REMOVALS.dwg, CO2, 2022-06-24 10:23 am rthomson

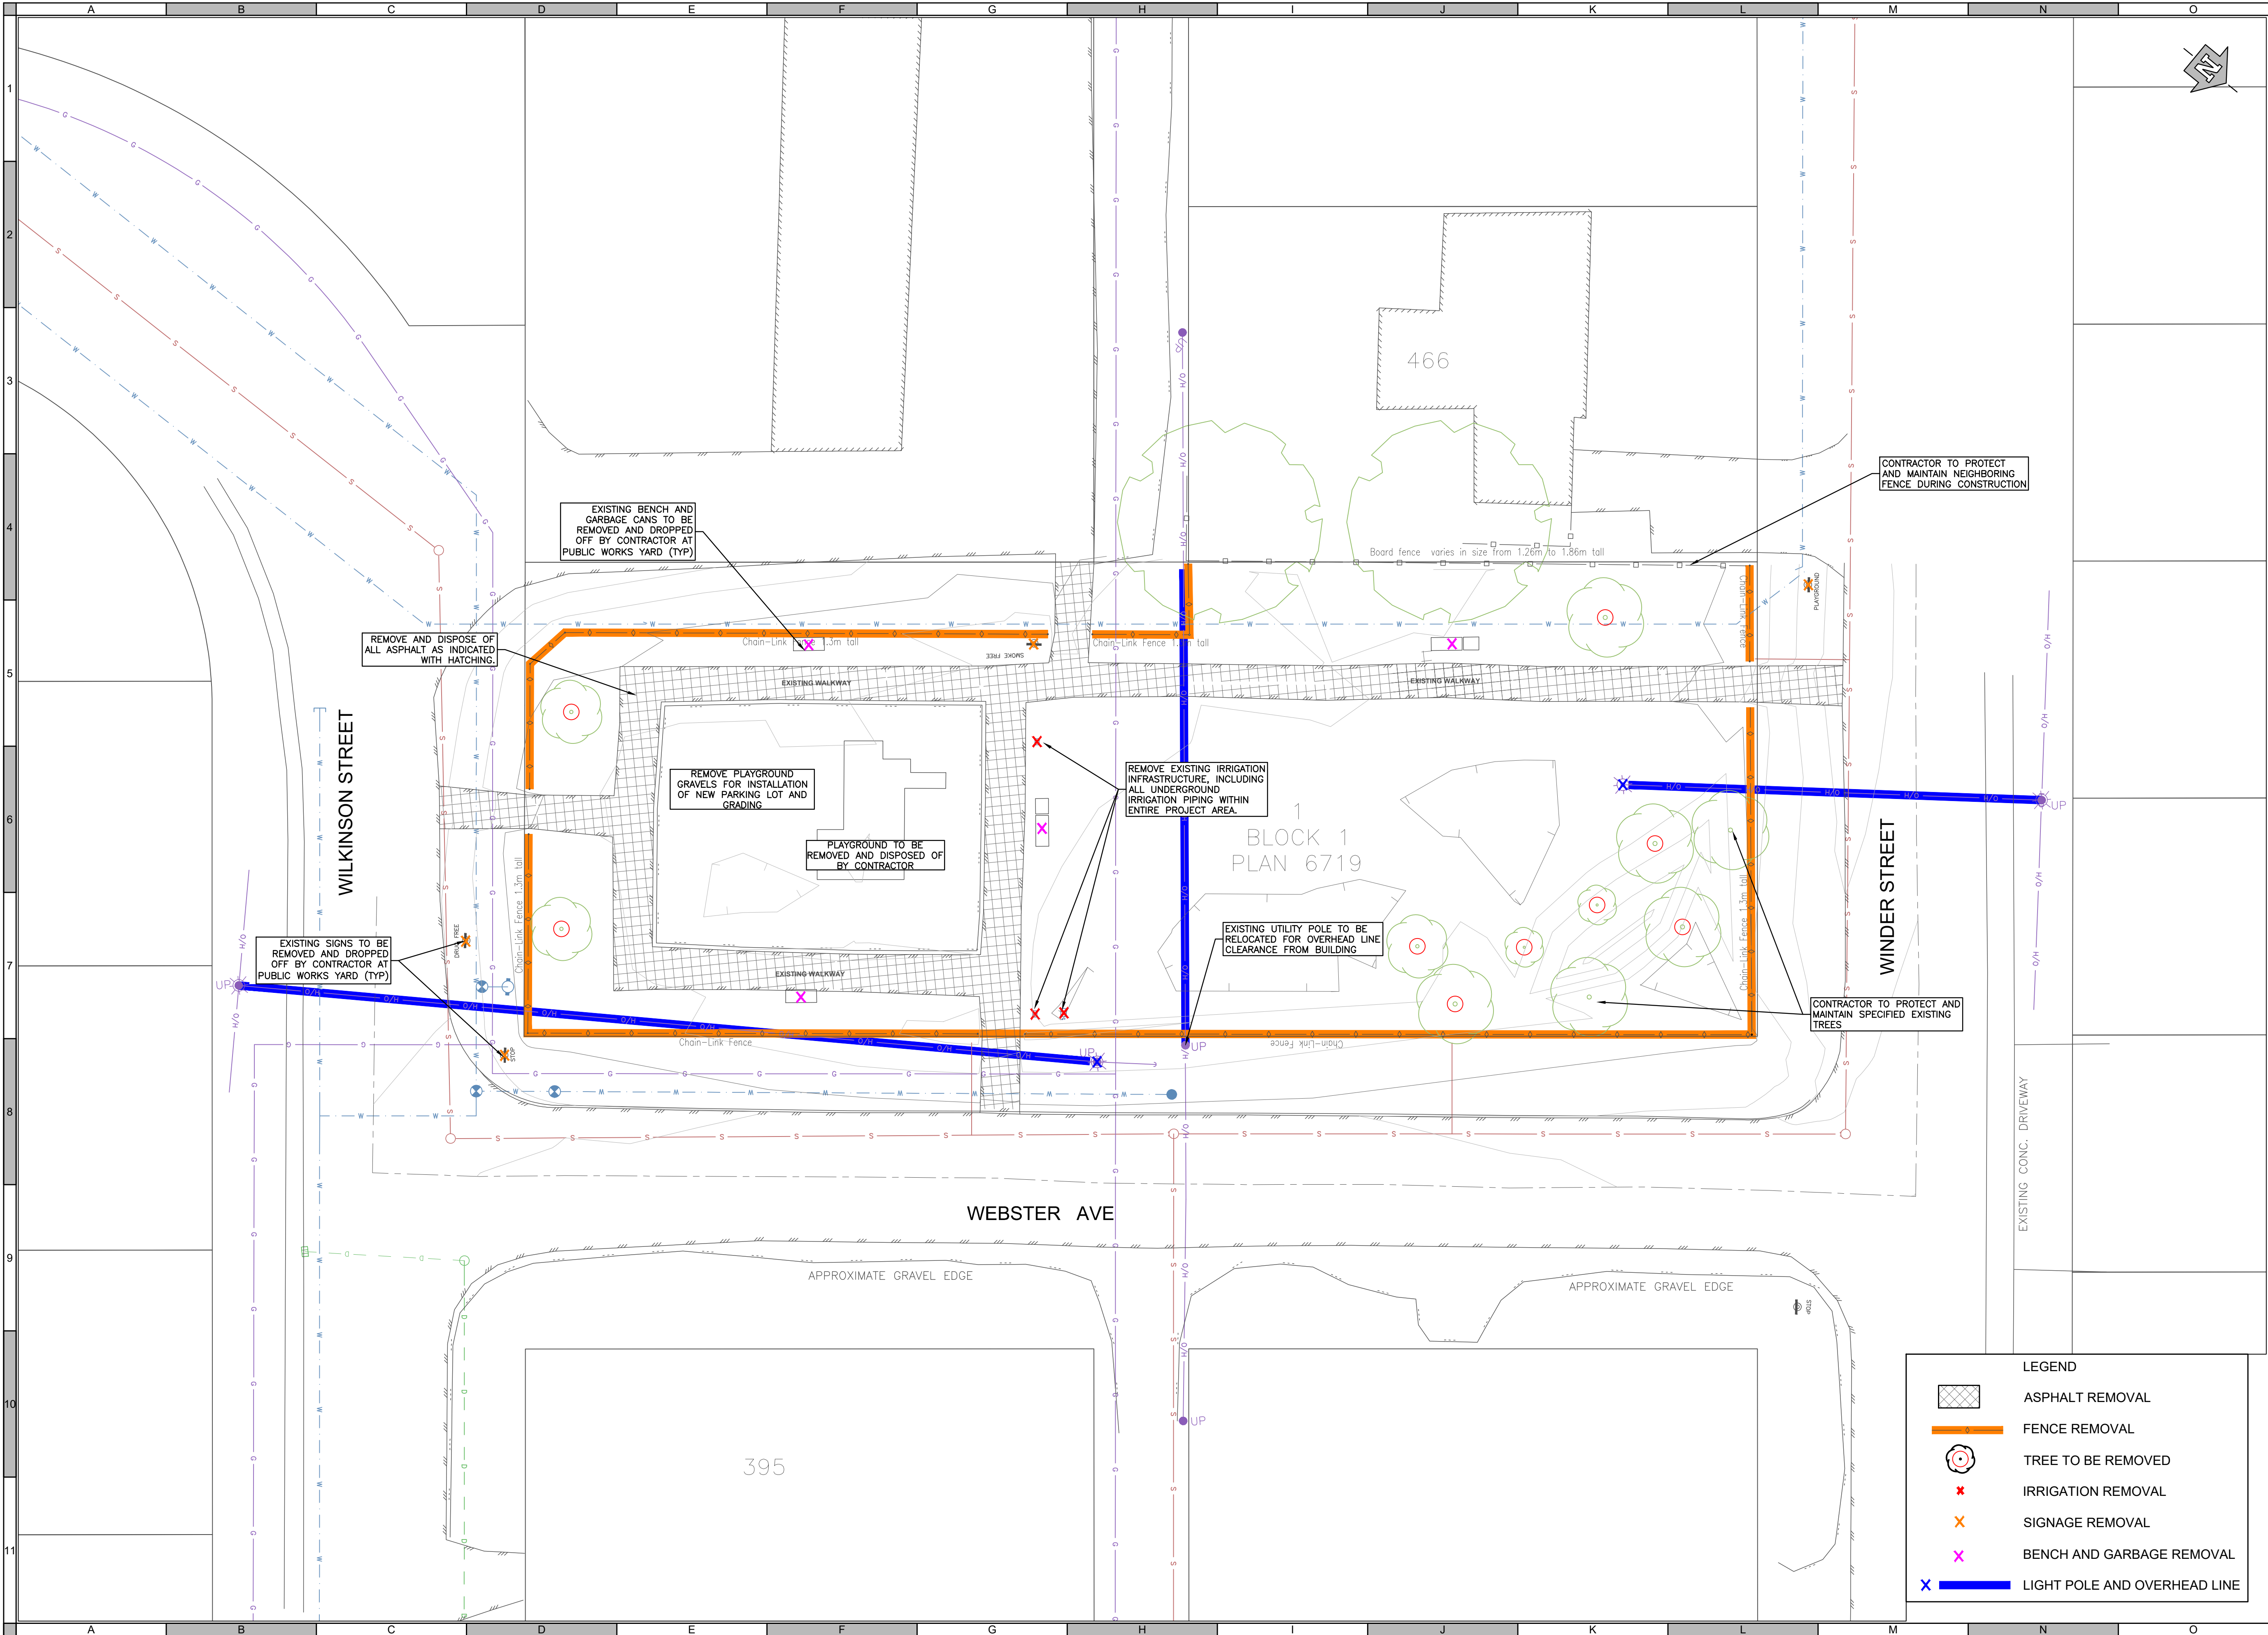

**ATTENTION**  
This drawing is prepared for the sole use of City of Quesnel  
No representations of any kind are made by Urban Systems Ltd. or its employees to any party with whom Urban Systems Ltd. does not have a contract.

**WARNING**  
Utilities or structures shown on this drawing were compiled from information supplied by various parties and may not be complete or accurate. Expose and conclusively confirm the location in the field all underground utilities and structures indicated on this drawing, all underground utilities in the area of the proposed work and any utilities or structures reasonably apparent from an inspection of the proposed work. Urban Systems Ltd. assumes no responsibility for loss or damage caused by third party negligence or failure to comply with the above.

**SURVEY INFORMATION**  
Prepared by: WILES SURVEYING  
Coordinate System: NAD83 (CSRS) 2002.0 UTM ZONE 10  
Compilation Date: 2021-08-31

**ISSUED FOR BP / TENDER**  
JUNE 24, 2022  
urbansystems.ca

Professional Seals

PROFESSIONAL  
PROVINCE OF  
R. M. D'AMOURS  
# 50280  
ENGINEERING  
2022-06-24

PERMIT TO PRACTICE  
URBAN SYSTEMS LTD.  
Signature: [Signature]  
Date: 2022-06-24  
PERMIT NUMBER: 1000527  
Engineers and Geoscientists BC  
(EGBC)

#	Date	Issue / Revision	App
A	2022-06-10	Issued For Review	RD
B	2022-06-24	Issued For BP / Tender	RD

**CITY OF Quesnel**

**URBAN SYSTEMS**

Scale 0 4 8m  
1:200

Quality Control by R. D'Amours  
Designed by R. Thomson  
Drawn by M. MacDonald

**Q-Kids Daycare Center REMOVALS**

Sheet Number 2 of 8  
Project Number Drawing Number Revision  
1190020001 C02 B


NOT FOR CONSTRUCTION







U:\Projects\_KAM\1190\0200\0101D-Design\CAD\20\_PROD\SET\_1\04-C05\_1190\2001 GRADING.dwg; C04\_2022-06-24 10:24 am rthomson

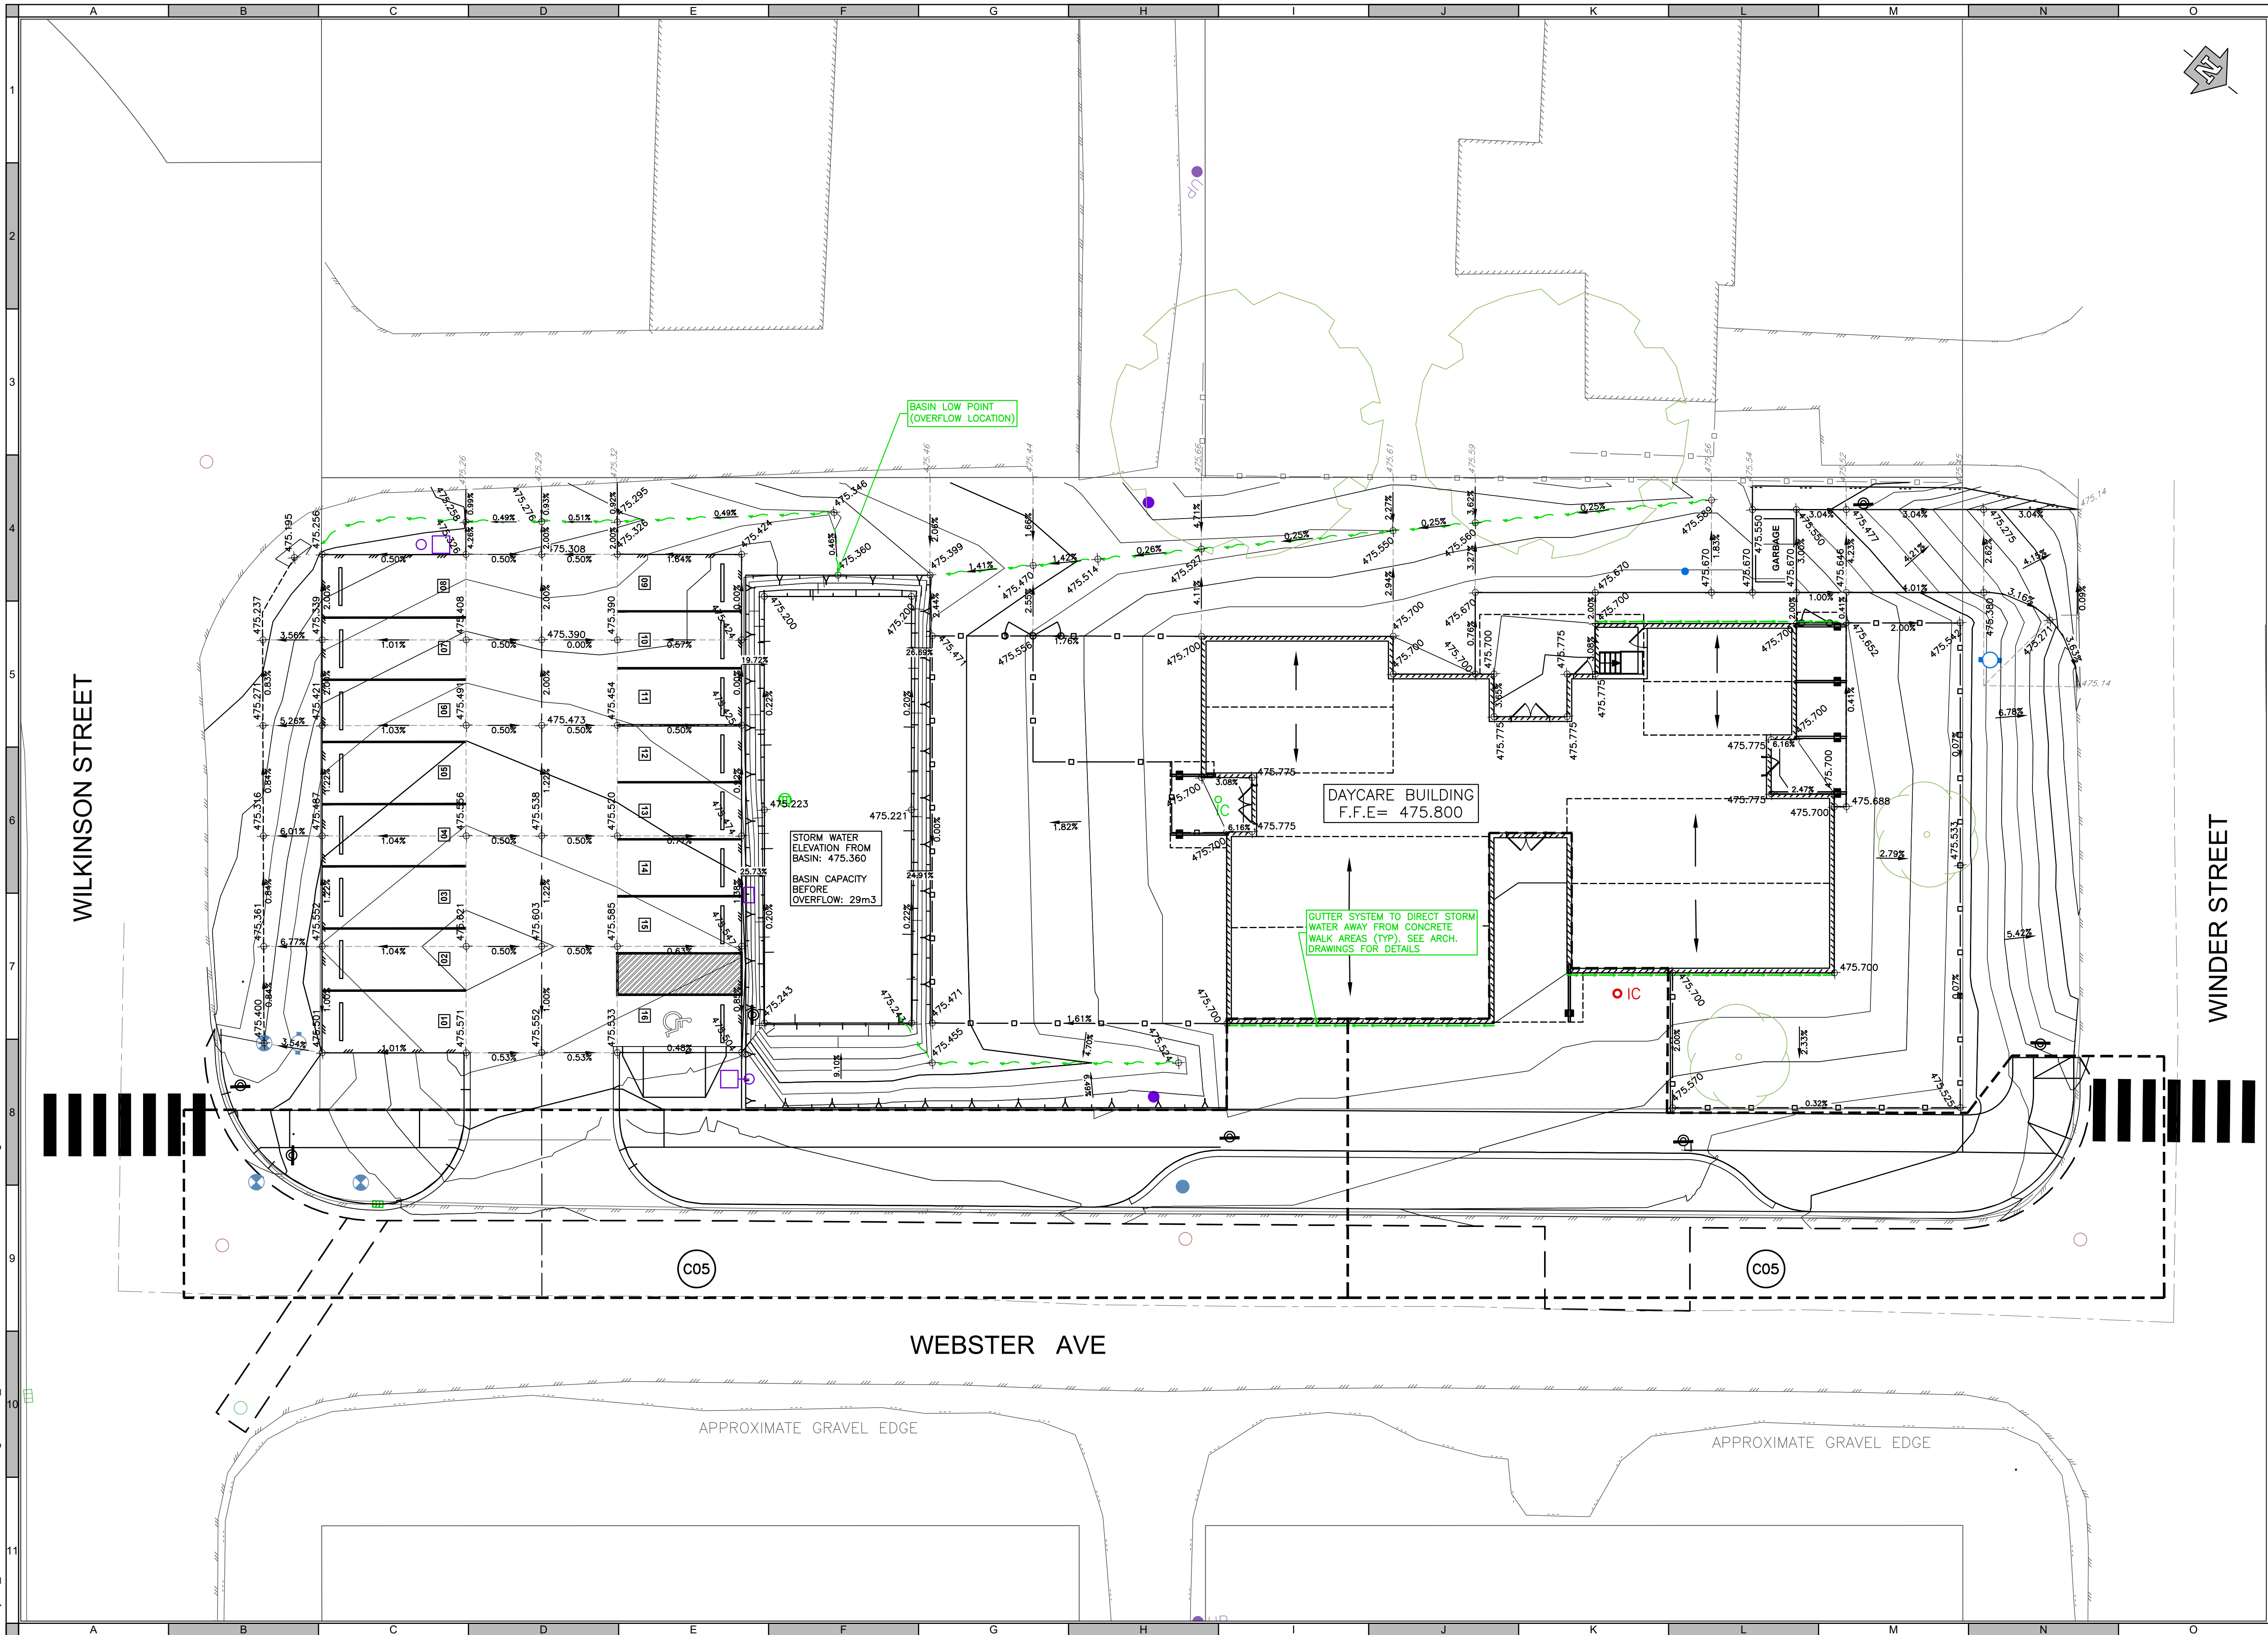

**ATTENTION**  
This drawing is prepared for the sole use of City of Quesnel.  
No representations of any kind are made by Urban Systems Ltd. or its employees to any party with whom Urban Systems Ltd. does not have a contract.

**WARNING**  
Utilities or structures shown on this drawing were compiled from information supplied by various parties and may not be complete or accurate. Expose and conclusively confirm the location in the field all underground utilities and structures indicated on this drawing, all underground utilities in the area of the proposed work and any utilities or structures reasonably apparent from an inspection of the proposed work. Urban Systems Ltd. assumes no responsibility for loss or damage caused by third party negligence or failure to comply with the above.

**SURVEY INFORMATION**  
Prepared by: WILES SURVEYING  
Coordinate System: NAD83 (CSRS) 2002.0 UTM ZONE 10  
Compilation Date: 2021-08-31

**ISSUED FOR BP / TENDER**  
JUNE 24, 2022  
urbansystems.ca

Professional Seals



PERMIT TO PRACTICE  
URBAN SYSTEMS LTD.  
Signature: [Signature]  
Date: 2022-06-24  
PERMIT NUMBER: 1000527  
Engineers and Geoscientists BC (EGBC)

#	Date	Issue / Revision	App
A	2022-06-10	Issued For Review	RD
B	2022-06-24	Issued For BP / Tender	RD



**URBAN SYSTEMS**

Scale 0 3 6m  
1:150

Quality Control by R. D'Amours  
Designed by R. Thomson  
Drawn by M. MacDonald

**Q-Kids Daycare Center**  
GRADING PLAN



Sheet Number 4 of 8  
Project Number Drawing Number Revision  
1190020001 C04 B

ANSI expand D (34.00 x 22.00 inches) 25mm

NOT FOR CONSTRUCTION



U:\Projects\_KAM\1190\020\010\10-Design\CAD\20\_PROD\SET\_1\04-C05\_1190\2001 GRADING.dwg, C05, 2022-06-24 10:24 am rthomson

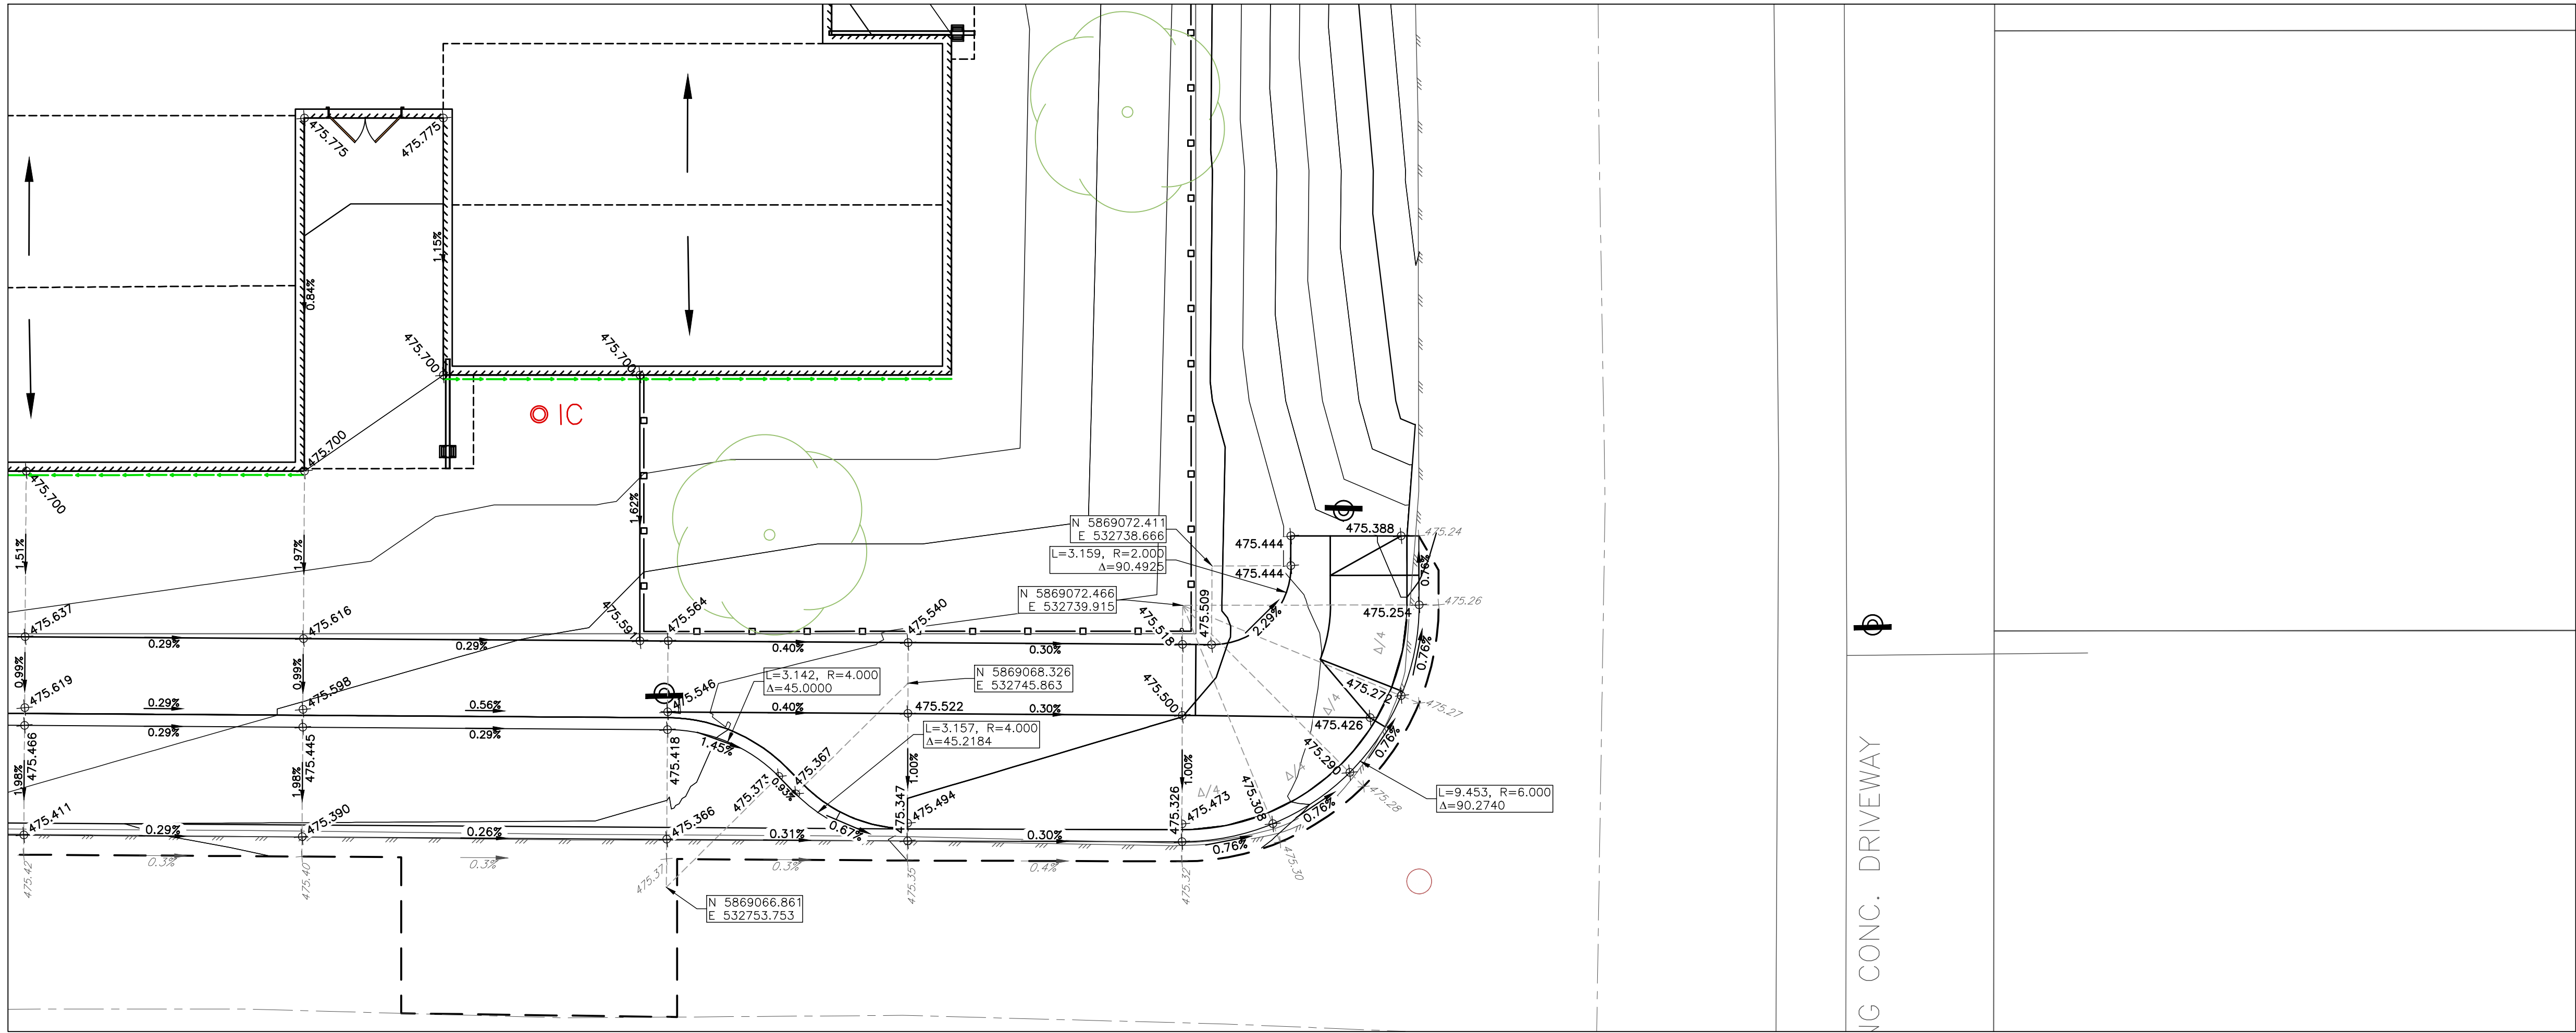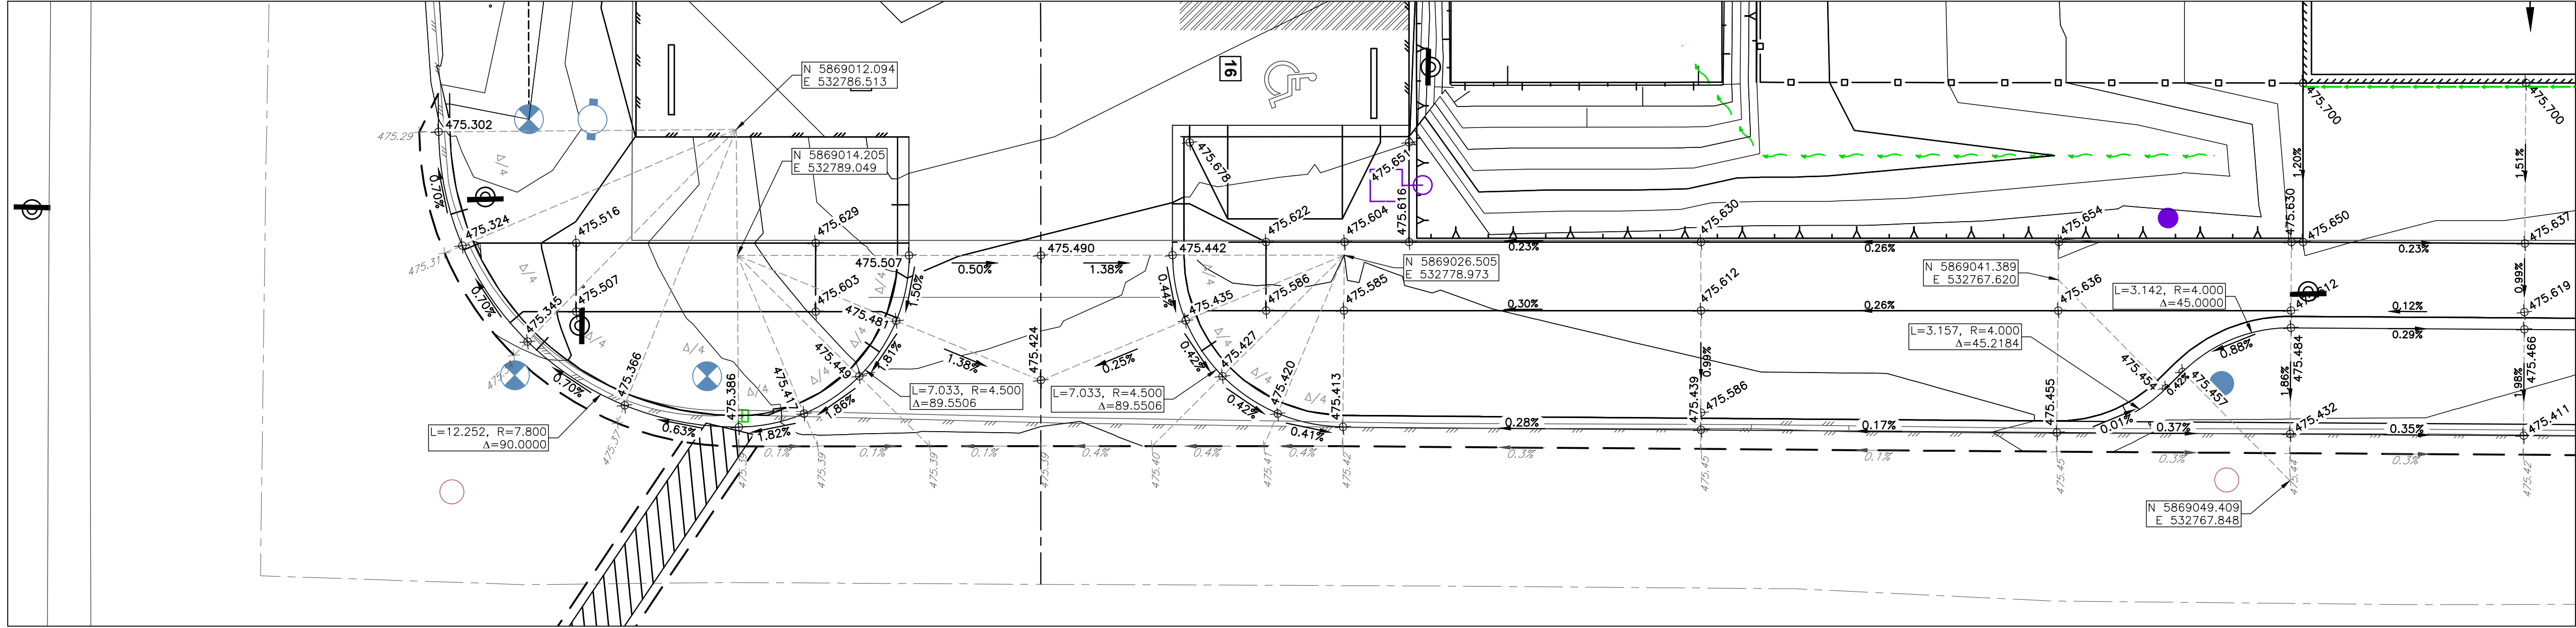

**ATTENTION**  
This drawing is prepared for the sole use of  
City of Quesnel  
No representations of any kind are made by Urban Systems Ltd.  
or its employees to any party with whom Urban Systems Ltd.  
does not have a contract.

**WARNING**  
Utilities or structures shown on this drawing were compiled from  
information supplied by various parties and may not be complete  
or accurate. Expose and conclusively confirm the location in the  
field all underground utilities and structures indicated on this  
drawing, all underground utilities in the area of the proposed  
work and any utilities or structures reasonably apparent from an  
inspection of the proposed work. Urban Systems Ltd. assumes  
no responsibility for loss or damage caused by third party  
negligence or failure to comply with the above.

**SURVEY INFORMATION**  
Prepared by: WILES SURVEYING  
Coordinate System: NAD83 (CSRS) 2002.0 UTM ZONE 10  
Compilation Date: 2021-08-31

**ISSUED FOR  
BP / TENDER**  
JUNE 24, 2022  
urbansystems.ca

Professional Seals



**PERMIT TO PRACTICE**  
URBAN SYSTEMS LTD.  
Signature: [Signature]  
Date: 2022-06-24  
PERMIT NUMBER: 1000527  
Engineers and Geoscientists BC  
(EGBC)

#	Date	Issue / Revision	App
A	2022-06-10	Issued For Review	RD
B	2022-06-24	Issued For BP / Tender	RD

**CITY OF  
Quesnel**

**URBAN  
SYSTEMS**

Scale  
1:100  
0 2 4m

Quality Control by: R. D'Amours  
Designed by: R. Thomson  
Drawn by: M. MacDonald


**Q-Kids Daycare Center  
GRADING DETAILS**

Sheet Number: 5 of 8  
Project Number: 1190020001  
Drawing Number: C05  
Revision: B

ANSI expand D (34.00 x 22.00 inches) 25mm

NOT FOR CONSTRUCTION

U:\Projects\_KAM\1190\020\010\1D-Design\CAD\20\_PROD\SET\_1\06 1190020001\_SIGNING & PAINT.dwg C06 2022-06-24 10:24 am rthomson

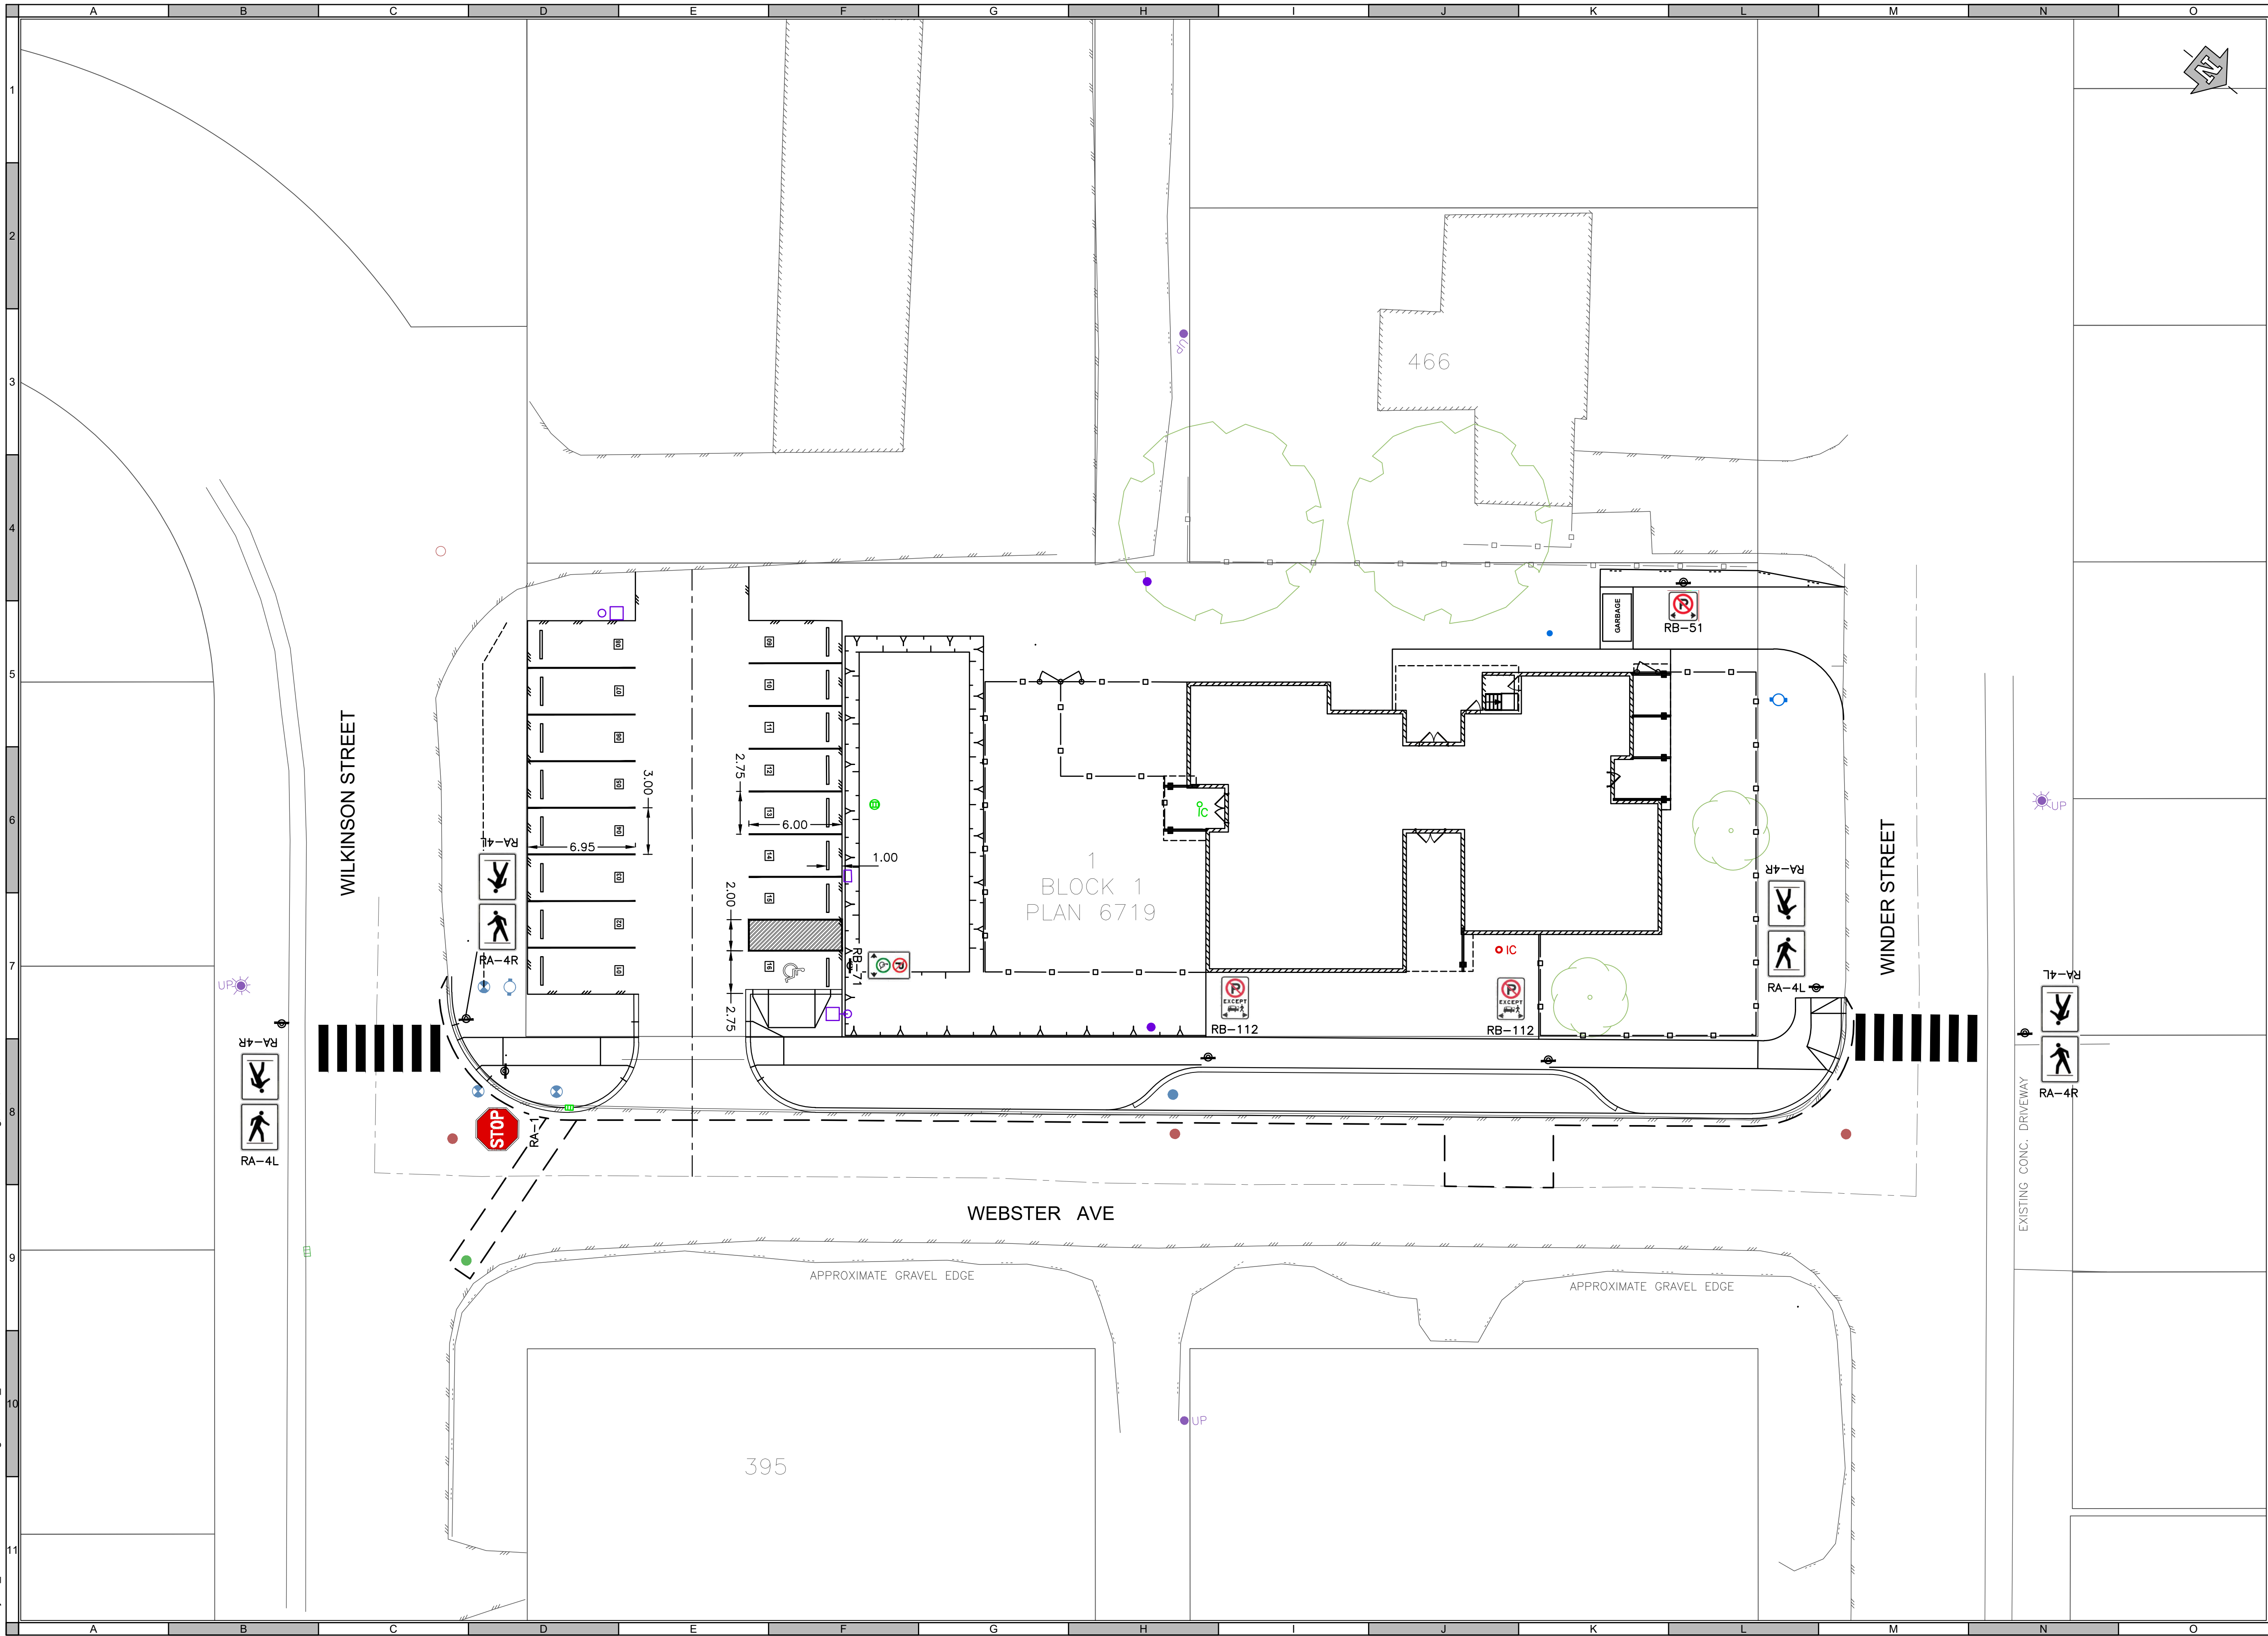

**ATTENTION**  
This drawing is prepared for the sole use of  
City of Quesnel  
No representations of any kind are made by Urban Systems Ltd.  
or its employees to any party with whom Urban Systems Ltd.  
does not have a contract.

**WARNING**  
Utilities or structures shown on this drawing were compiled from  
information supplied by various parties and may not be complete  
or accurate. Expose and conclusively confirm the location in the  
field all underground utilities and structures indicated on this  
drawing, all underground utilities in the area of the proposed  
work and any utilities or structures reasonably apparent from an  
inspection of the proposed work. Urban Systems Ltd. assumes  
no responsibility for loss or damage caused by third party  
negligence or failure to comply with the above.

**SURVEY INFORMATION**  
Prepared by: WILES SURVEYING  
Coordinate System: NAD83 (CSRS) 2002.0 UTM ZONE 10  
Compilation Date: 2021-08-31

**ISSUED FOR  
BP / TENDER**  
JUNE 24, 2022  
urbansystems.ca

Professional Seals

PROFESSIONAL  
ENGINEER  
R. M. D'AMOURS  
# 50280  
2022-06-24

PERMIT TO PRACTICE  
URBAN SYSTEMS LTD.  
Signature: [Signature]  
Date: 2022-06-24  
PERMIT NUMBER: 1000527  
Engineers and Geoscientists BC  
(EGBC)

#	Date	Issue / Revision	App
A	2022-06-10	Issued For Review	RD
B	2022-06-24	Issued For BP / Tender	RD

**CITY OF  
Quesnel**

**URBAN  
SYSTEMS**

Scale 1:200 0 4 8m

Quality Control by R. D'Amours  
Designed by R. Thomson  
Drawn by M. MacDonald


**Q-Kids Daycare Center  
SIGNING & PAINT**

Sheet Number	6 of 8
Project Number	1190020001
Drawing Number	C06
Revision	B


NOT FOR CONSTRUCTION




U:\Projects\_KAM\1190\02001010-Design\CAD\20\_PROD\SET 1\07-1190020001 DETAILS.dwg, C07, 2022-06-24 10:25 am thomson

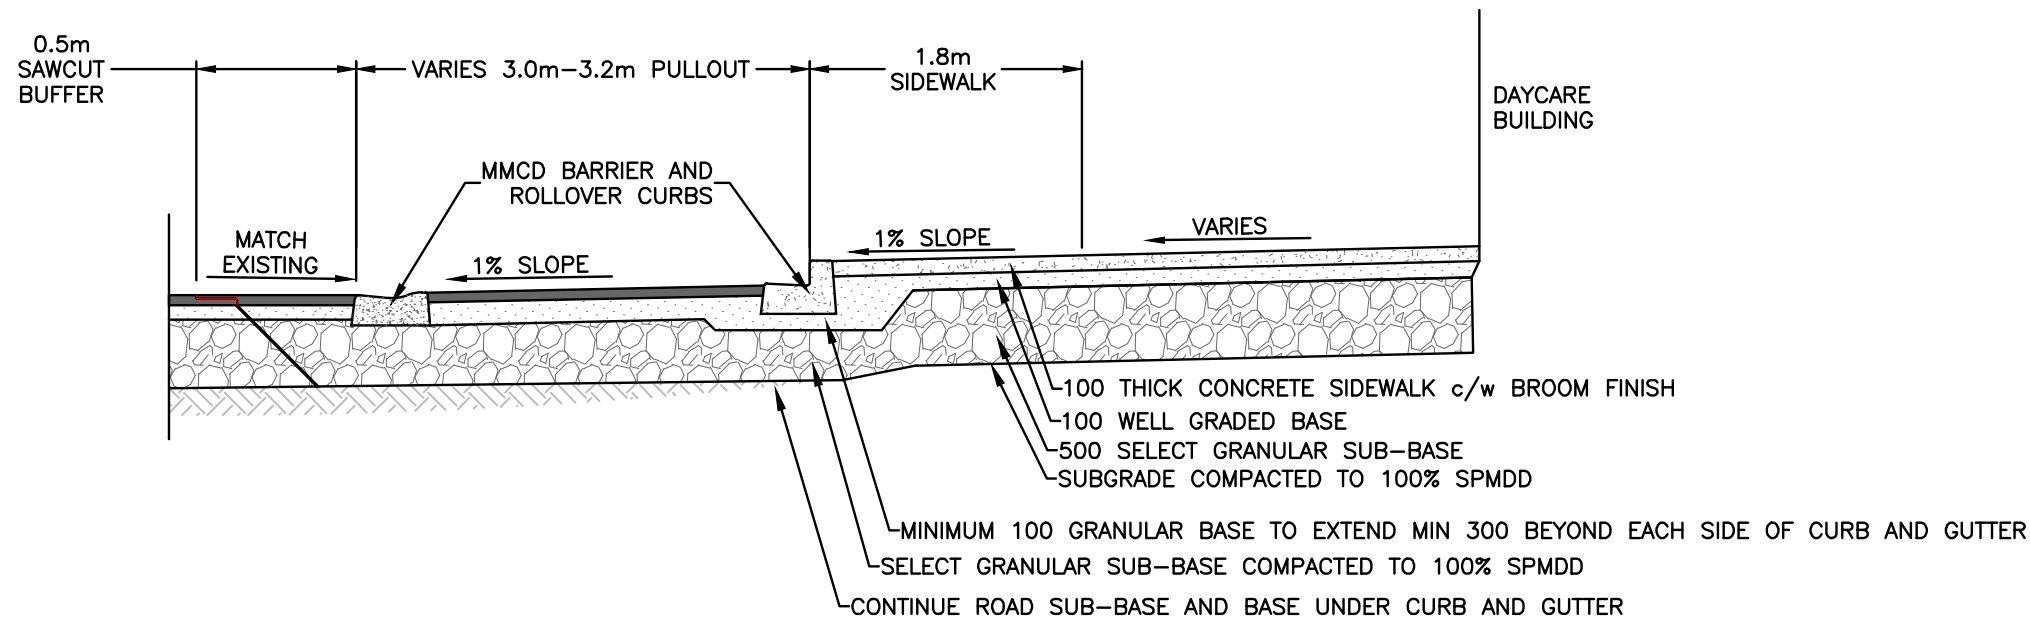

1 PULLOUT AREA AND SIDEWALK DETAIL

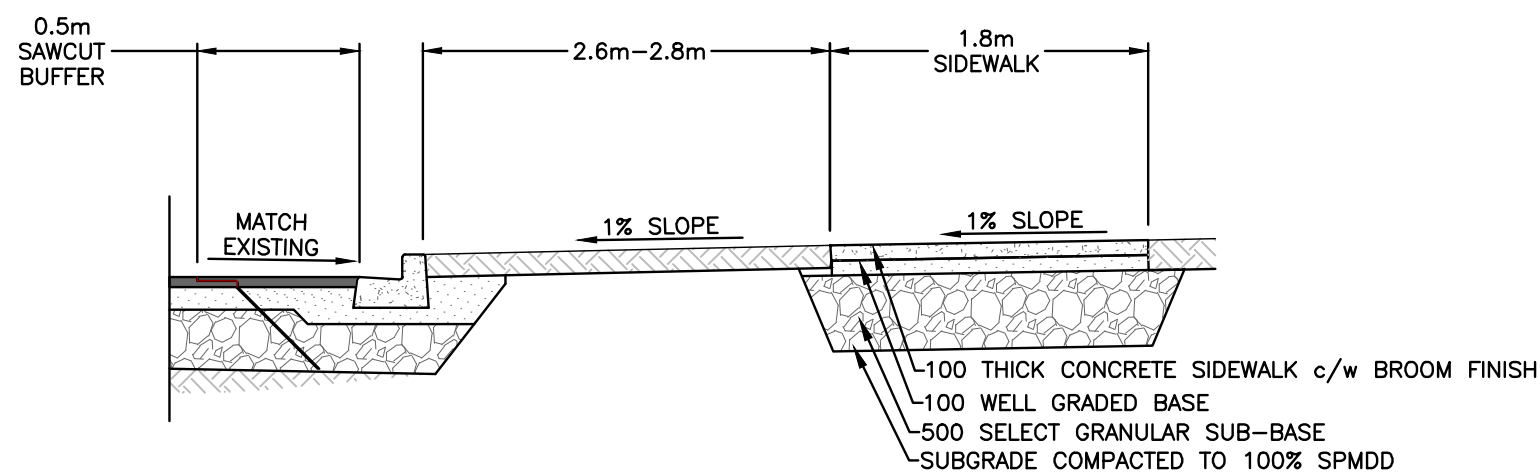


2 CURB AND BOULEVARD DETAIL

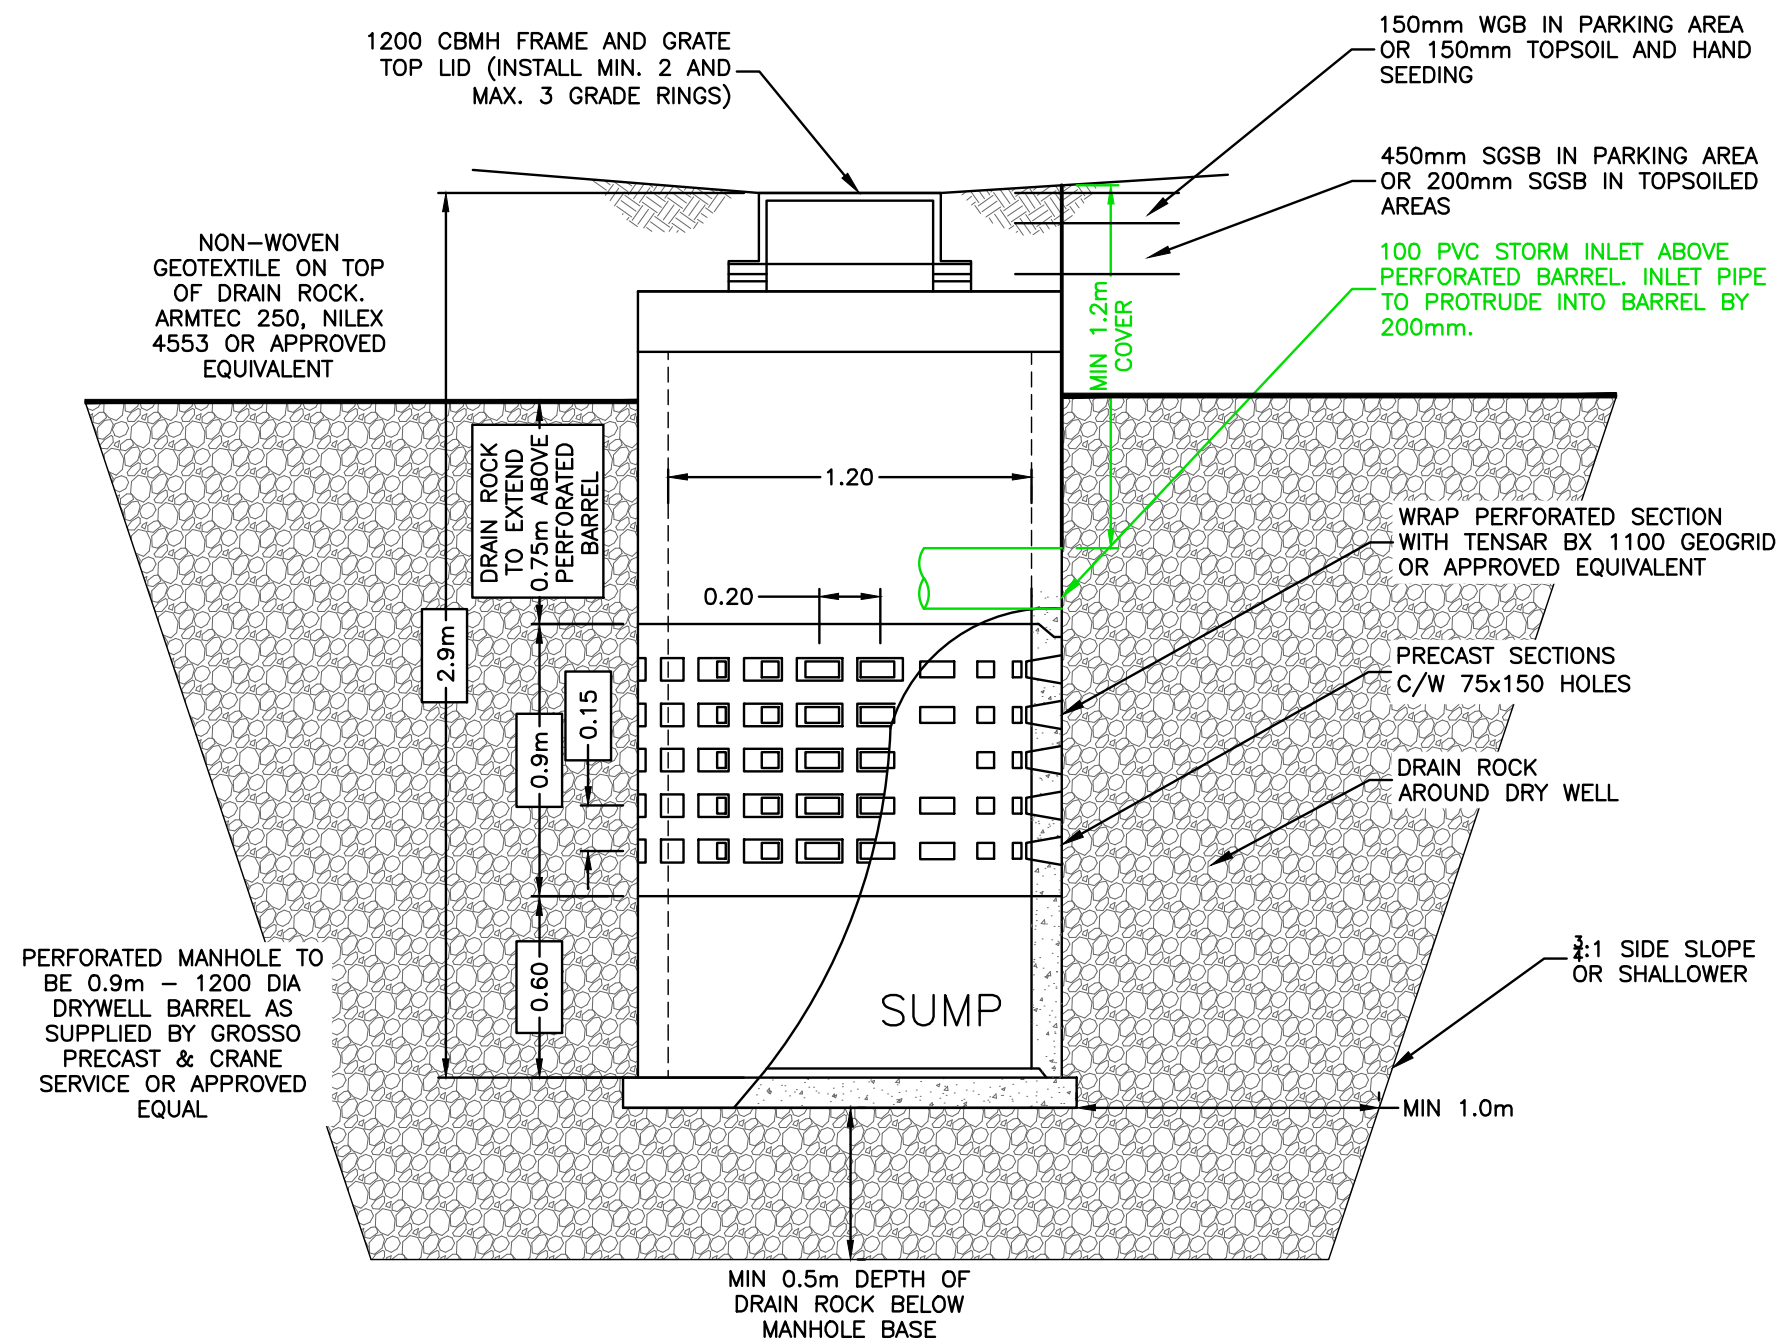


NOTES:  
1. COVER CLAYS/SILTS EXPOSED IN SIDES OF EXCAVATION AT DEPTH OF MANHOLE PERFORATIONS WITH NON-WOVEN GEOTEXTILE.


6 DRY WELL

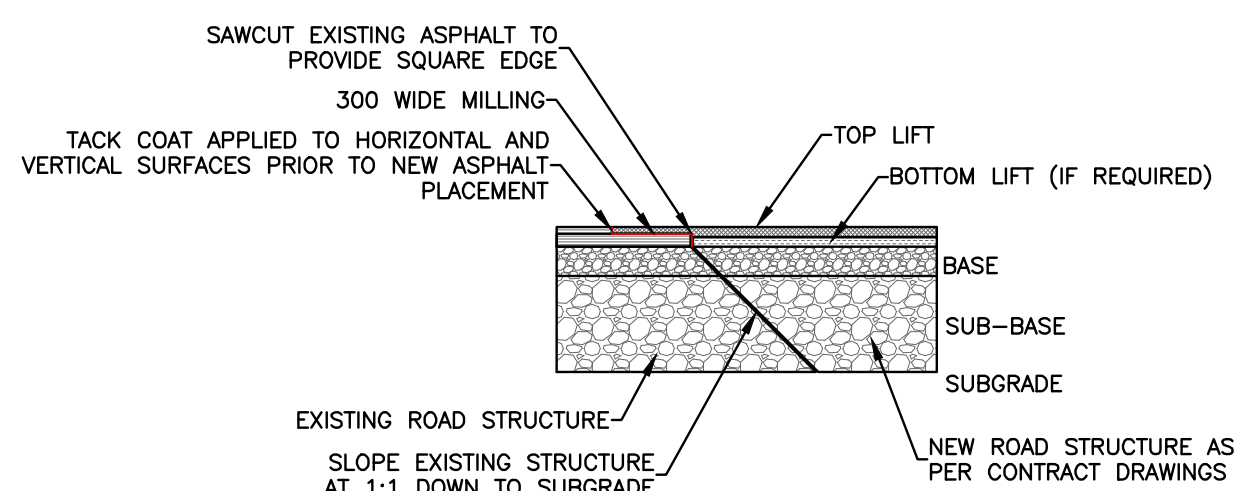

3 SAWCUT TIE IN

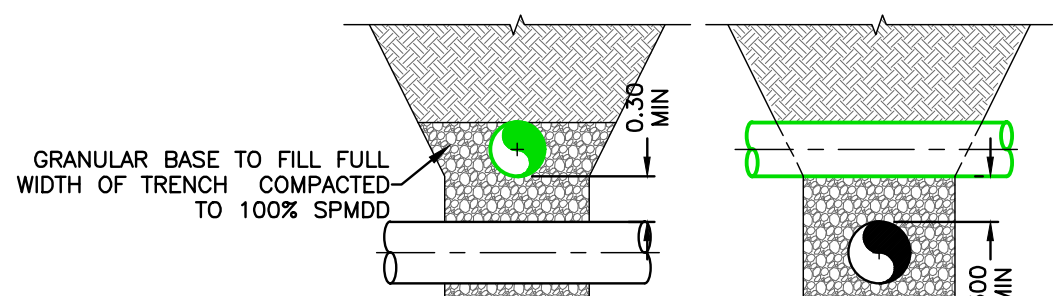

4 PIPE CROSSING

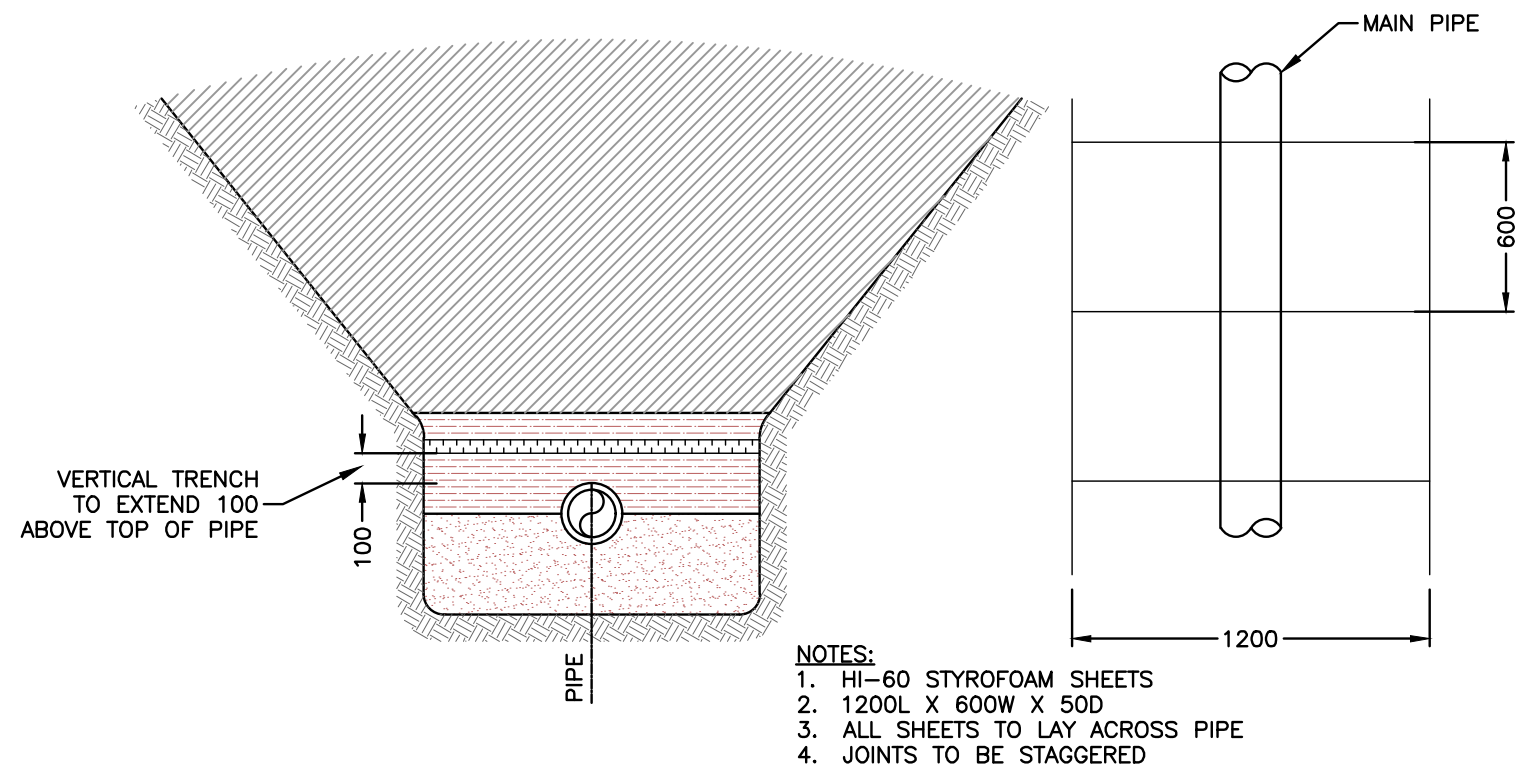

NOTES:  
1. HI-60 STYROFOAM SHEETS  
2. 1200L X 600W X 50D  
3. ALL SHEETS TO LAY ACROSS PIPE  
4. JOINTS TO BE STAGGERED

5 PIPE INSULATION


ATTENTION  
This drawing is prepared for the sole use of City of Quesnel  
No representations of any kind are made by Urban Systems Ltd. or its employees to any party with whom Urban Systems Ltd. does not have a contract.

WARNING  
Utilities or structures shown on this drawing were compiled from information supplied by various parties and may not be complete or accurate. Expose and conclusively confirm the location in the field all underground utilities and structures indicated on this drawing, all underground utilities in the area of the proposed work and any utilities or structures reasonably apparent from an inspection of the proposed work. Urban Systems Ltd. assumes no responsibility for loss or damage caused by third party negligence or failure to comply with the above.

SURVEY INFORMATION  
Prepared by: WILES SURVEYING  
Coordinate System: NAD83 (CSRS) 2002.0 UTM ZONE 10  
Compilation Date: 2021-08-31

ISSUED FOR  
BP / TENDER  
JUNE 24, 2022  
urbansystems.ca

Professional Seals

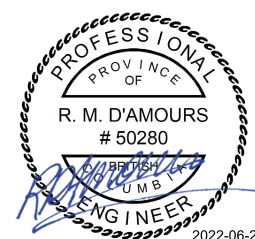

PERMIT TO PRACTICE  
URBAN SYSTEMS LTD.  
Signature: [Signature]  
Date: 2022-06-24  
PERMIT NUMBER: 1000527  
Engineers and Geoscientists BC (EGBC)

#	Date	Issue / Revision	App
A	2022-06-10	Issued For Review	RD
B	2022-06-24	Issued For BP / Tender	RD

CITY OF  
Quesnel

URBAN  
SYSTEMS

Scale  
NOT TO SCALE

Quality Control by R. D'Amours  
Designed by R. Thomson  
Drawn by M. MacDonald

Q-Kids Daycare Center  
DETAILS


Sheet Number 7 of 8  
Project Number Drawing Number Revision  
1190020001 C07 B

ANSI expand D (34.00 x 22.00 inches) 25mm


NOT FOR CONSTRUCTION



U:\Projects\_KAM\1190\0200\01\01D-Design\CAD\20\_PROD\SET\_1\C03 1190020001 SITE PLAN.dwg, C06, 2022-06-24 10:25 am rthomson

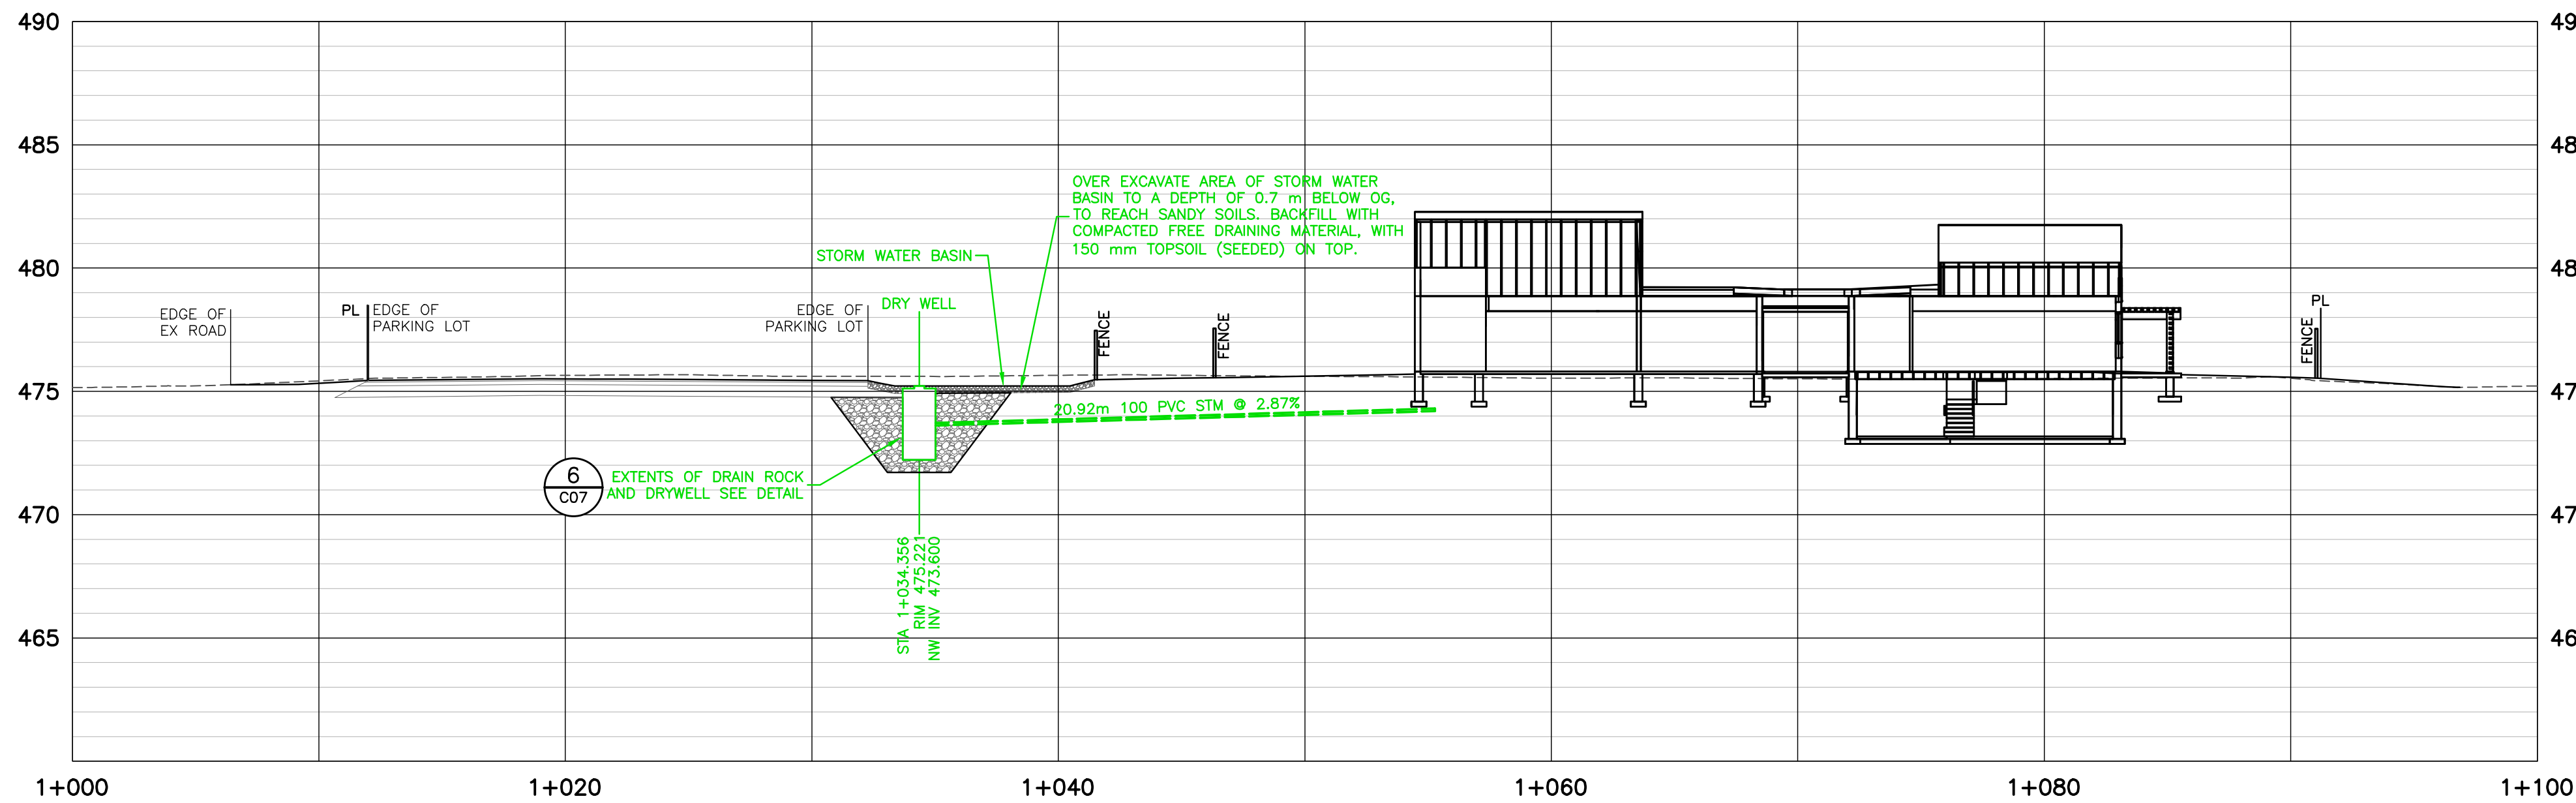

A N-S SITE SECTION  
C03  
0m 2 4 6

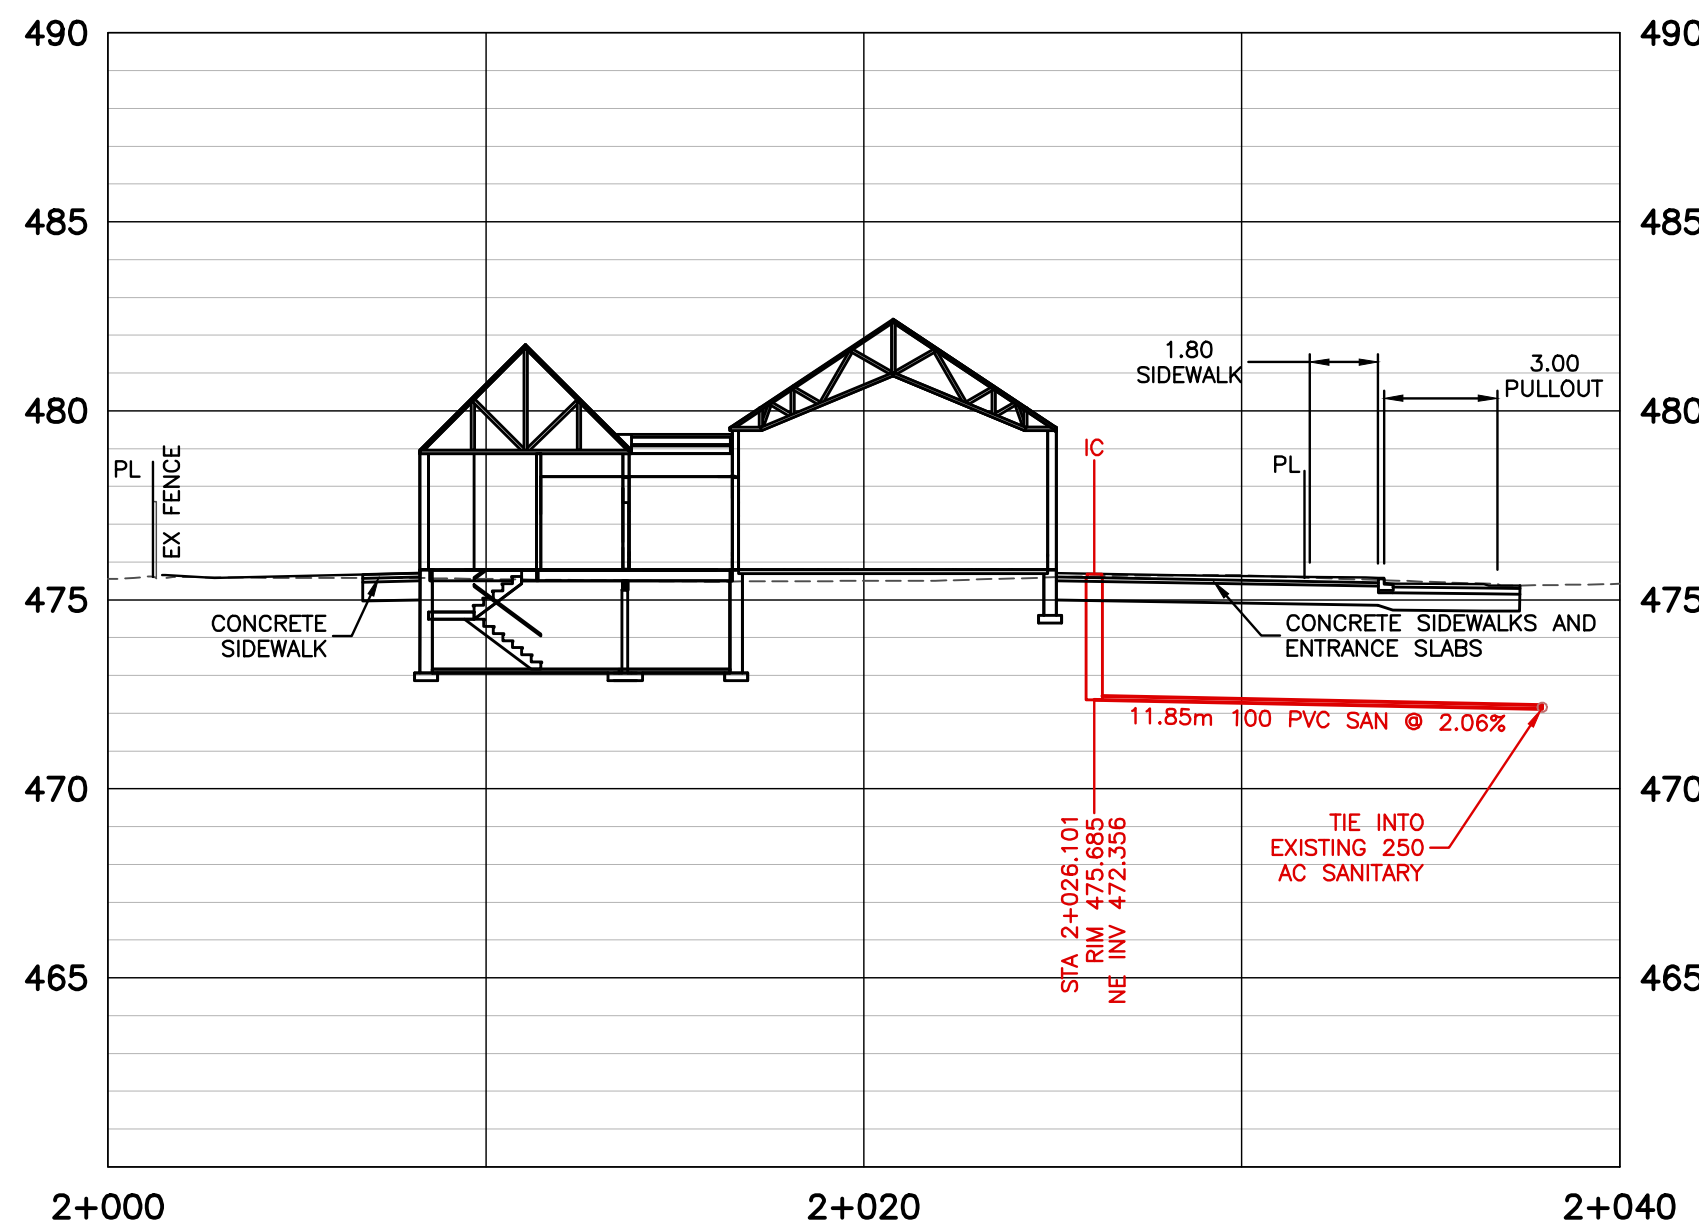

B E-W SITE SECTION  
C03  
0m 2 4 6


ATTENTION  
This drawing is prepared for the sole use of  
City of Quesnel  
No representations of any kind are made by Urban Systems Ltd.  
or its employees to any party with whom Urban Systems Ltd.  
does not have a contract.

WARNING  
Utilities or structures shown on this drawing were compiled from  
information supplied by various parties and may not be complete  
or accurate. Expose and conclusively confirm the location in the  
field all underground utilities and structures indicated on this  
drawing, all underground utilities in the area of the proposed  
work and any utilities or structures reasonably apparent from an  
inspection of the proposed work. Urban Systems Ltd. assumes  
no responsibility for loss or damage caused by third party  
negligence or failure to comply with the above.

SURVEY INFORMATION  
Prepared by: WILES SURVEYING  
Coordinate System: NAD83 (CSRS) 2002.0 UTM ZONE 10  
Compilation Date: 2021-08-31

ISSUED FOR  
BP / TENDER  
JUNE 24, 2022  
urbansystems.ca

Professional Seals

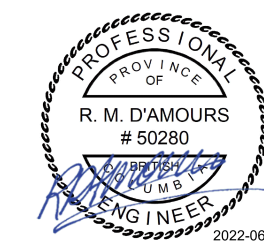

PERMIT TO PRACTICE  
URBAN SYSTEMS LTD.  
Signature: [Signature]  
Date: 2022-06-24  
PERMIT NUMBER: 1000527  
Engineers and Geoscientists BC  
(EGBC)

#	Date	Issue / Revision	App
A	2022-06-10	Issued For Review	RD
B	2022-06-24	Issued For BP / Tender	RD



**URBAN**  
SYSTEMS

Scale 0 4 8m  
1:200

Quality Control by R. D'Amours  
Designed by R. Thomson  
Drawn by M. MacDonald

Q-Kids Daycare Center  
SECTIONS  
Station to

Sheet Number 8 of 8  
Project Number Drawing Number Revision  
1190020001 C08 B

NOT FOR CONSTRUCTION